


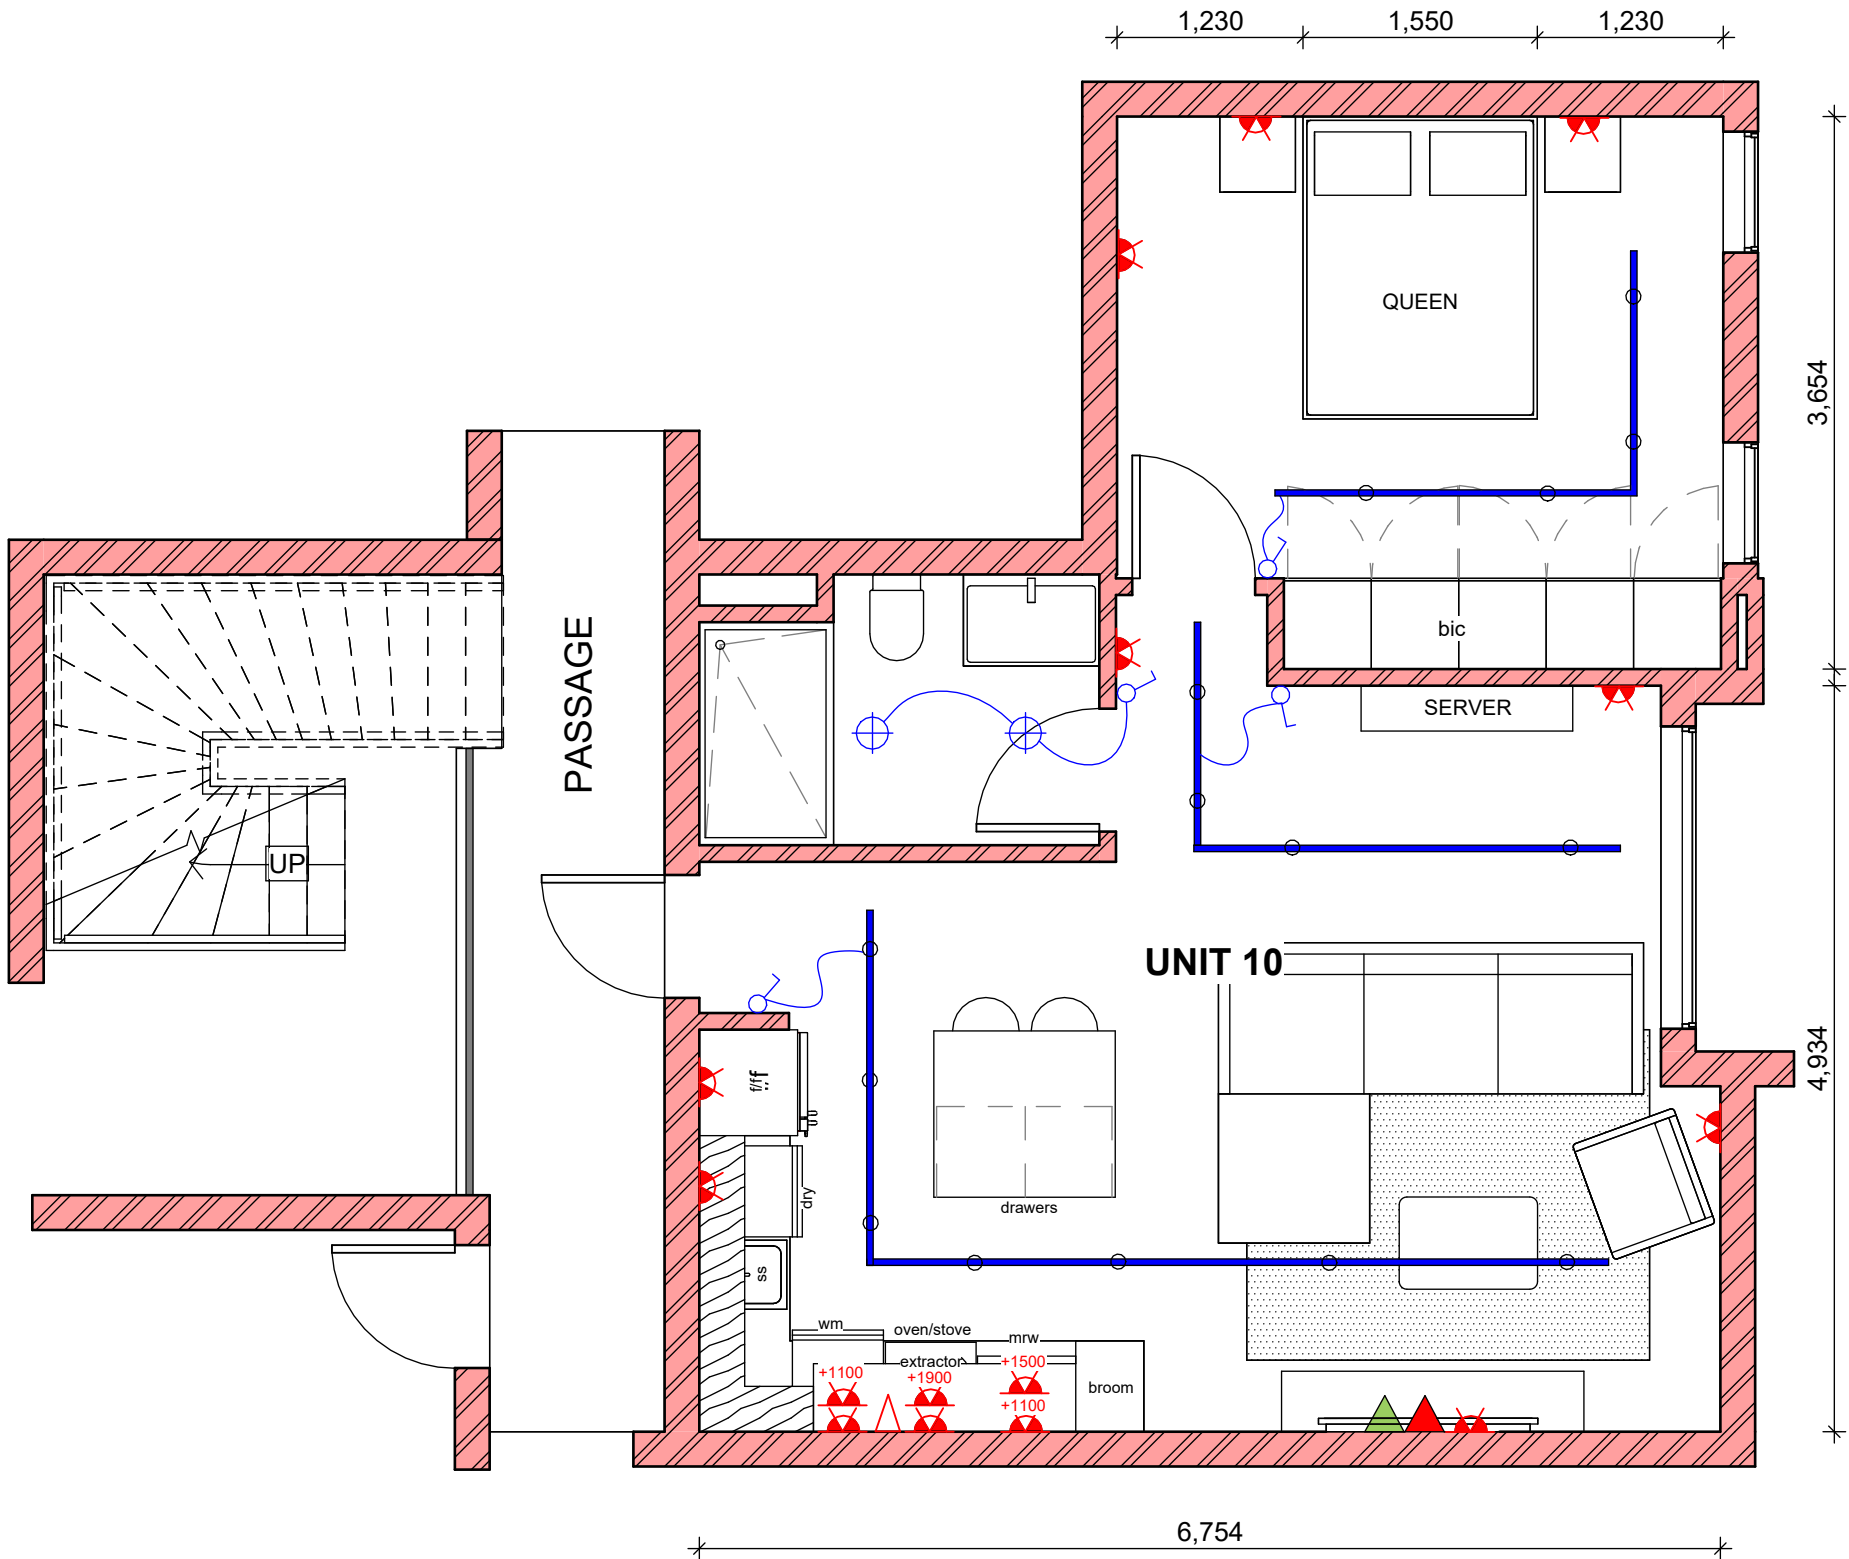

ONE BEDROOM UNIT _ TYPICAL LAYOUT
FF - UNIT 10, SINGLE STORY

ELECTRICAL LEGEND

	2 PIN & 3 PIN SWITCHED SOCKET OUTLET MOUNTED FLUSH AT 300mm A.F.F.L UNLESS OTHERWISE INDICATED.
	ISOLATOR SWITCH
	FIBRE/INTERNET POINT
	TV SATELITE DISH POINT
	ELECTRICAL DISTRIBUTION BOARD, PLACEMENT TO BE CONFIRMED

LIGHTING LEGEND

	SURFACE MOUNTED DOWNLIGHT FITTING
	TRACK LIGHTING WITH ADJUSTABLE SPOTLIGHTING
	OUTDOOR LIGHT FITTING
	FLUORESCENT LIGHT FITTING
	SINGLE LEVER, 1 WAY, LIGHT SWITCH MOUNTED AT +1200mm A.F.F.L. '2' DENOTES A TWO WAY SWITCH

GENERAL NOTE:

ALL LEVELS AND DIMENSIONS ARE TO BE
CHECKED ON SITE BEFORE THE
COMMENCEMENT OF ANY WORK. ANY
DISCREPANCIES ARE TO BE REPORTED TO
THE INTERIOR DESIGNER IMMEDIATELY.

PLEASE NOTE THAT IF ANY DETAIL,
DESCRIPTION AND/OR SPECIFICATION ON
THIS DRAWING AND/OR LEGEND IS
UNCLEAR AND/OR FURTHER INFORMATION
IS REQUIRED THAT WOULD DETER AND/OR
DELAY SUCCESSFUL IMPLEMENTATION OF
PARTICULAR ELEMENT, SUCH ITEM
SHOULD BE REPORTED WITHOUT DELAY
TO THE INTERIOR DESIGNER. FAILING THIS
OPUS DESIGN STUDIO CAN NOT BE
HELD RESPONSIBLE FOR ANY DELAY
AND/OR ISSUE THAT WOULD RESULT FROM
INADEQUATE
COLLECTION/INTERPRETATION OF
INFORMATION OR LACK THEREOF.

REVISIONS:

No.	Description	Date

Suite 10, Building 6
Cnr of Holwood
Cres. &
Canegate Rd
Holwood Park
Umhlanga Ridge

T: 031 265 2991/2
E: studio@opusdesign.co.za
W: www.opusdesign.co.za

PROJECT: ODS_111 - WESTBROOK DEVELOPMENT		
DRAWING: SPACE PLANNING, ELECTRICAL & LIGHTING _1 BED UNIT		
ISSUED FOR: INFORMATION		
SCALE: 1 : 50	DATE: 2023/07/10	DRAWN: TG
SHEET NO: 1	REV. NO: 00	REV. BY: 01