



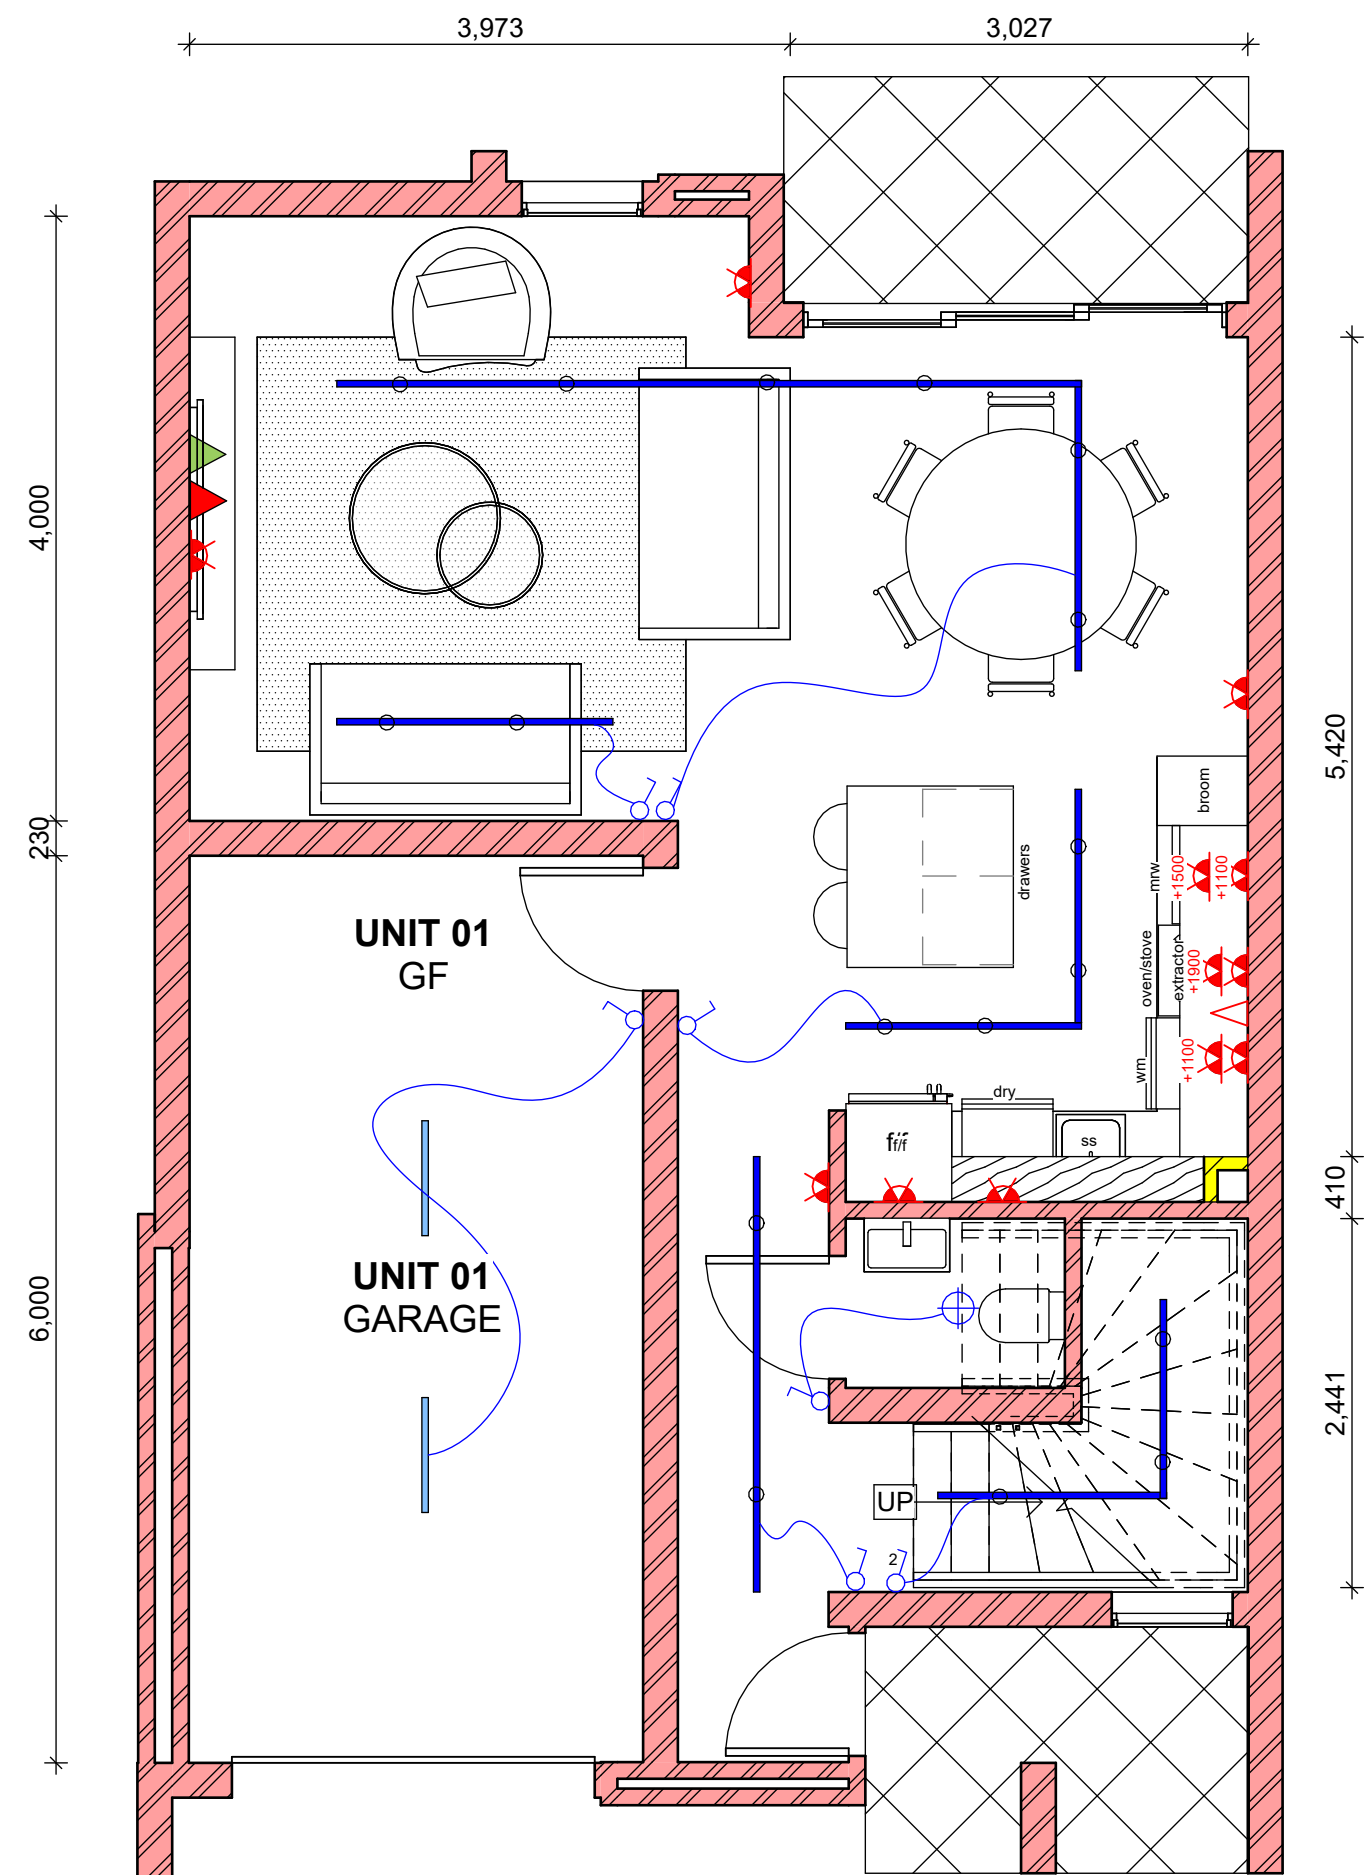

THREE BEDROOM UNIT _ TYPICAL LAYOUT
GF - UNIT 01, DOUBLE STORY

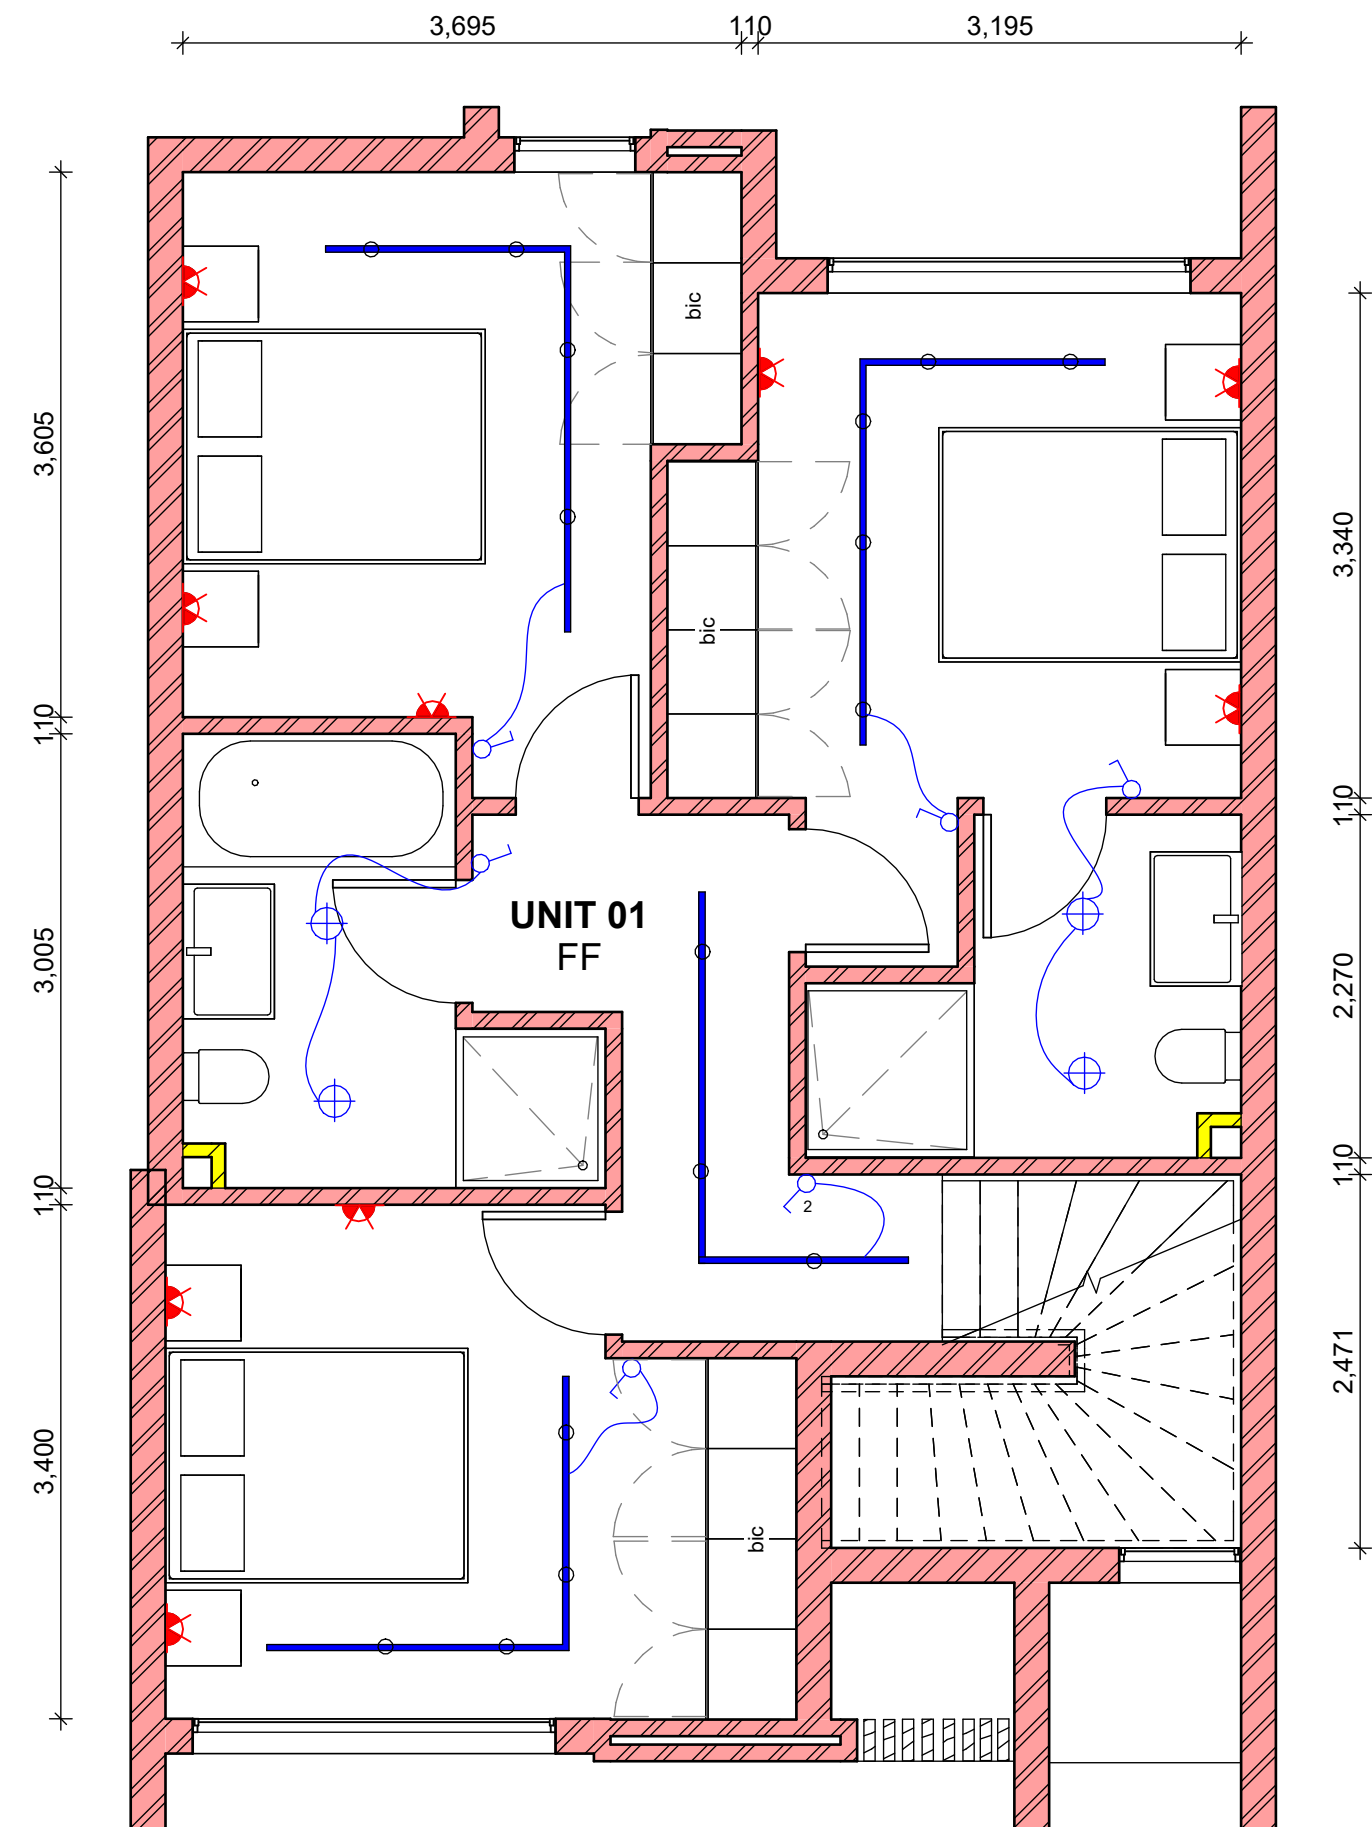

THREE BEDROOM UNIT _ TYPICAL LAYOUT
FF - UNIT 01, DOUBLE STORY

ELECTRICAL LEGEND	
	2 PIN & 3 PIN SWITCHED SOCKET OUTLET MOUNTED FLUSH AT 300mm A.F.F.L UNLESS OTHERWISE INDICATED.
	ISOLATOR SWITCH
	FIBRE/INTERNET POINT
	TV SATELITE DISH POINT
	ELECTRICAL DISTRIBUTION BOARD, PLACEMENT TO BE CONFIRMED

LIGHTING LEGEND	
	SURFACE MOUNTED DOWNLIGHT FITTING
	TRACK LIGHTING WITH ADJUSTABLE SPOTLIGHTING
	OUTDOOR LIGHT FITTING
	FLUORESCENT LIGHT FITTING
	SINGLE LEVER, 1 WAY, LIGHT SWITCH MOUNTED AT +1200mm A.F.F.L. '2' DENOTES A TWO WAY SWITCH

GENERAL NOTE:

ALL LEVELS AND DIMENSIONS ARE TO BE CHECKED ON SITE BEFORE THE COMMENCEMENT OF ANY WORK. ANY DISCREPANCIES ARE TO BE REPORTED TO THE INTERIOR DESIGNER IMMEDIATELY.

PLEASE NOTE THAT IF ANY DETAIL, DESCRIPTION AND/OR SPECIFICATION ON THIS DRAWING AND/OR LEGEND IS UNCLEAR AND/OR FURTHER INFORMATION IS REQUIRED THAT WOULD DETER AND/OR DELAY SUCCESSFUL IMPLEMENTATION OF PARTICULAR ELEMENT, SUCH ITEM SHOULD BE REPORTED WITHOUT DELAY TO THE INTERIOR DESIGNER. FAILING THIS OPUS DESIGN STUDIO CAN NOT BE HELD RESPONSIBLE FOR ANY DELAY AND/OR ISSUE THAT WOULD RESULT FROM INADEQUATE COLLECTION/INTERPRETATION OF INFORMATION OR LACK THEREOF.

REVISIONS:		
No.	Description	Date



Suite 10, Building 6
Cnr of Holwood Cres. & Canegate Rd
Holwood Park
Umhlanga Ridge

T: 031 265 2991/2
E: studio@opusdesign.co.za
W: www.opusdesign.co.za

PROJECT: ODS_111 - WESTBROOK DEVELOPMENT		
DRAWING: SPACE PLANNING, ELECTRICAL & LIGHTING _ 3 BED UNIT		
ISSUED FOR: INFORMATION		
SCALE: 1 : 50	DATE: 2023/07/10	DRAWN: TG
SHEET NO: 3	REV. NO: 00	REV. BY: 01